


MATCH LINE - SEE SHEET 1

MATCH LINE - SEE SHEET 4

no.	revision	date	by

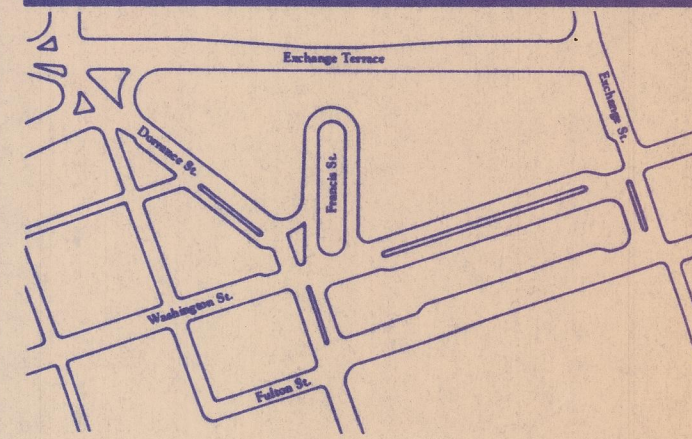

Kennedy Plaza

Transit Mall & Pedestrian Improvement Project

United States Department of Transportation
Urban Mass Transportation Administration
Providence Redevelopment Agency

Albert Veri & Associates, Inc.
60 Ship Street Providence Rhode Island 02903
401 274-1360
landscape architects/urban designers

Wallace Floyd Associates, Inc.
architects/planners
Lee Pare & Associates, Inc.
consulting engineers
Wilbur Smith Associates
traffic engineers
Kay Powell Associates & The Wissing Gengler Group, Inc.
signage consultants

drawing title

DRAINAGE & UTILITY PLAN No. 3

date 7-13-83 sheet of
scale 1"=20' drawing no.
drawn R. J. H.
checked J. L. B.